

NOTES:

ALL THE DIMENSIONS IN THIS SHEET ARE IN FEET & INCHES
GROUND FLOOR AT 3 FEET HEIGHT FROM FINISHED FLOOR LEVEL (PFL)

CEILING HEIGHT - 12'-0"
SLAB THICKNESS - 6"
PLINTH THICKNESS - 5"

SITE DIMENSIONS: 350'-0" X 390'-0"
SITE AREA : 1,29,000 SQ.FT.

LEGEND:

SYMBOLS	NAME	TYPE	Key
	SPRINKLER	WET PIPE FIRE	-
	FIRE ALARM	HEAT DETECTOR	-
	FIRST AID KIT	OFFICE AID	-
	FIRE EXTINGUISHER	WATER FIRE	-
	FIRE EXTINGUISHER	APF FOAM	-
	SIGN BOARDS	LEFT	-
	SIGN BOARDS	RIGHT	-
	FIRE BUCKETS	SAND	-
	FIRE HYDRANT	WATER FILLED	-
	PANIC DIRECTIONS	L.R.F.B	-

PROJECT NAME:

MULTIPLEX DESIGN

CLIENT NAME:

FLUX CINEMAS

DRAWING NAME:

FIRE & SAFETY LAYOUT

NAME:


HUZefa KAPI

DATE: 21/03/19

SHEET NUMBER:

SCALE: 1:250

07

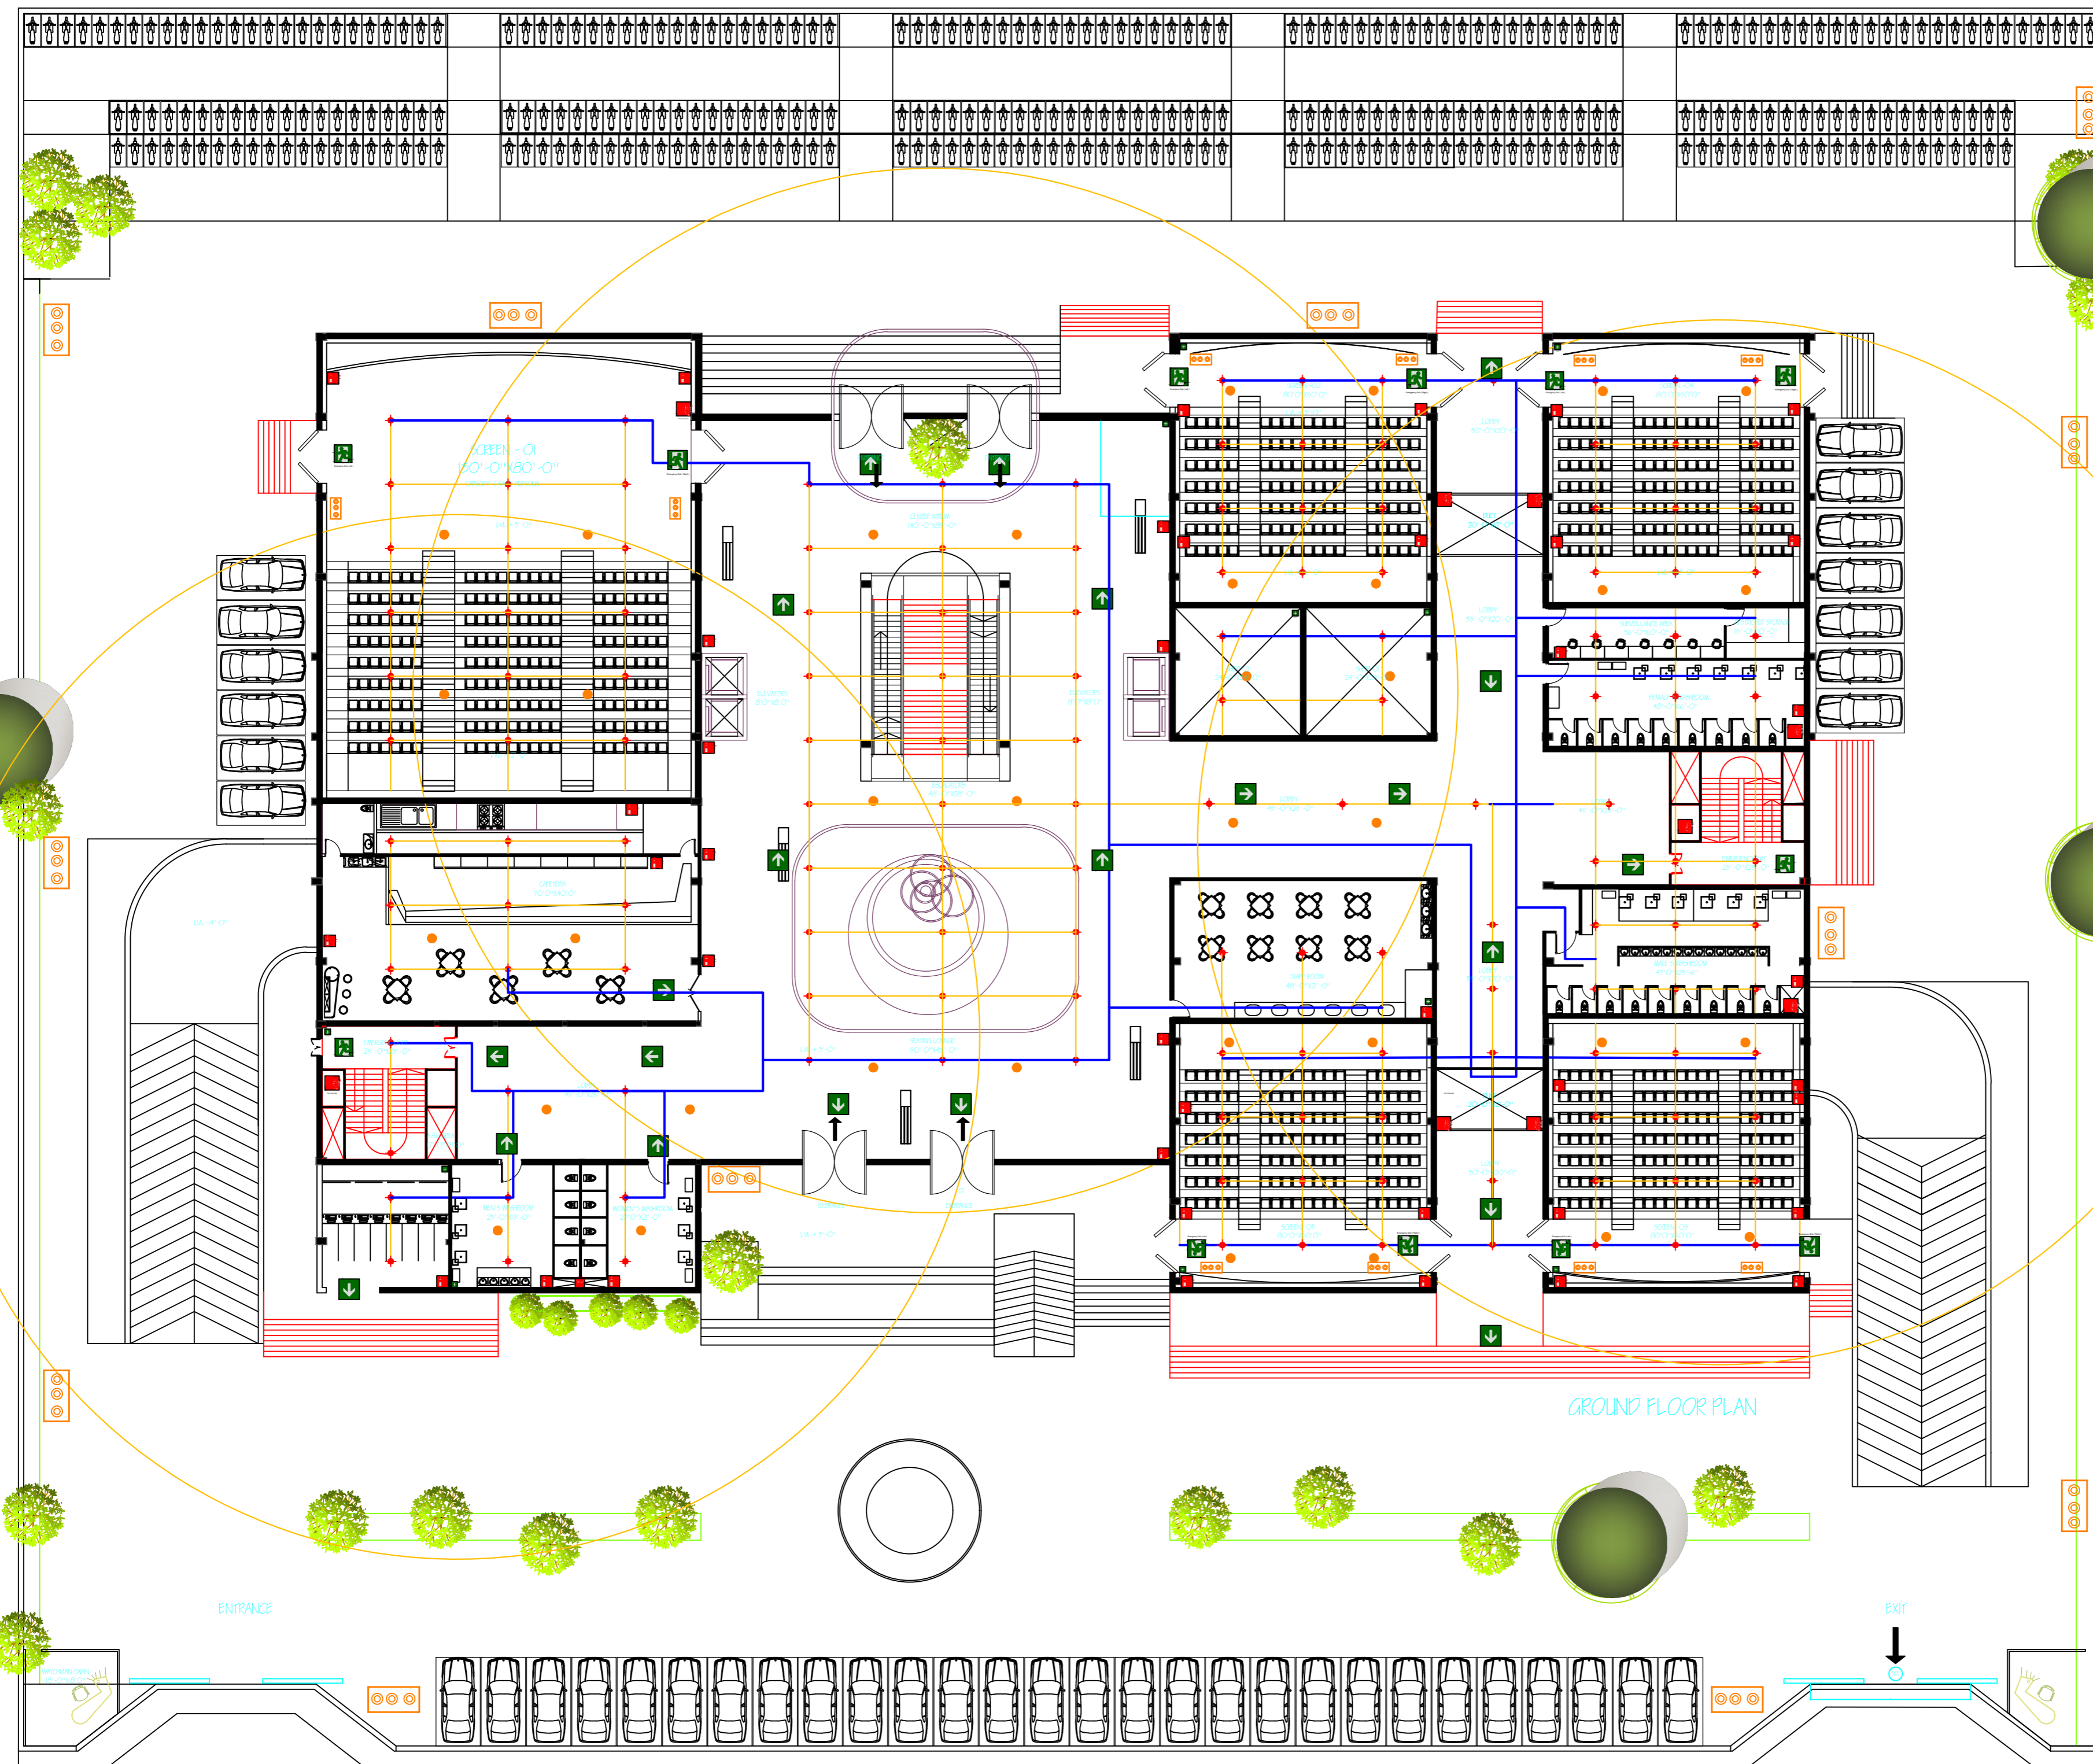

GROUND FLOOR PLAN

ENTRANCE

EXIT